
 
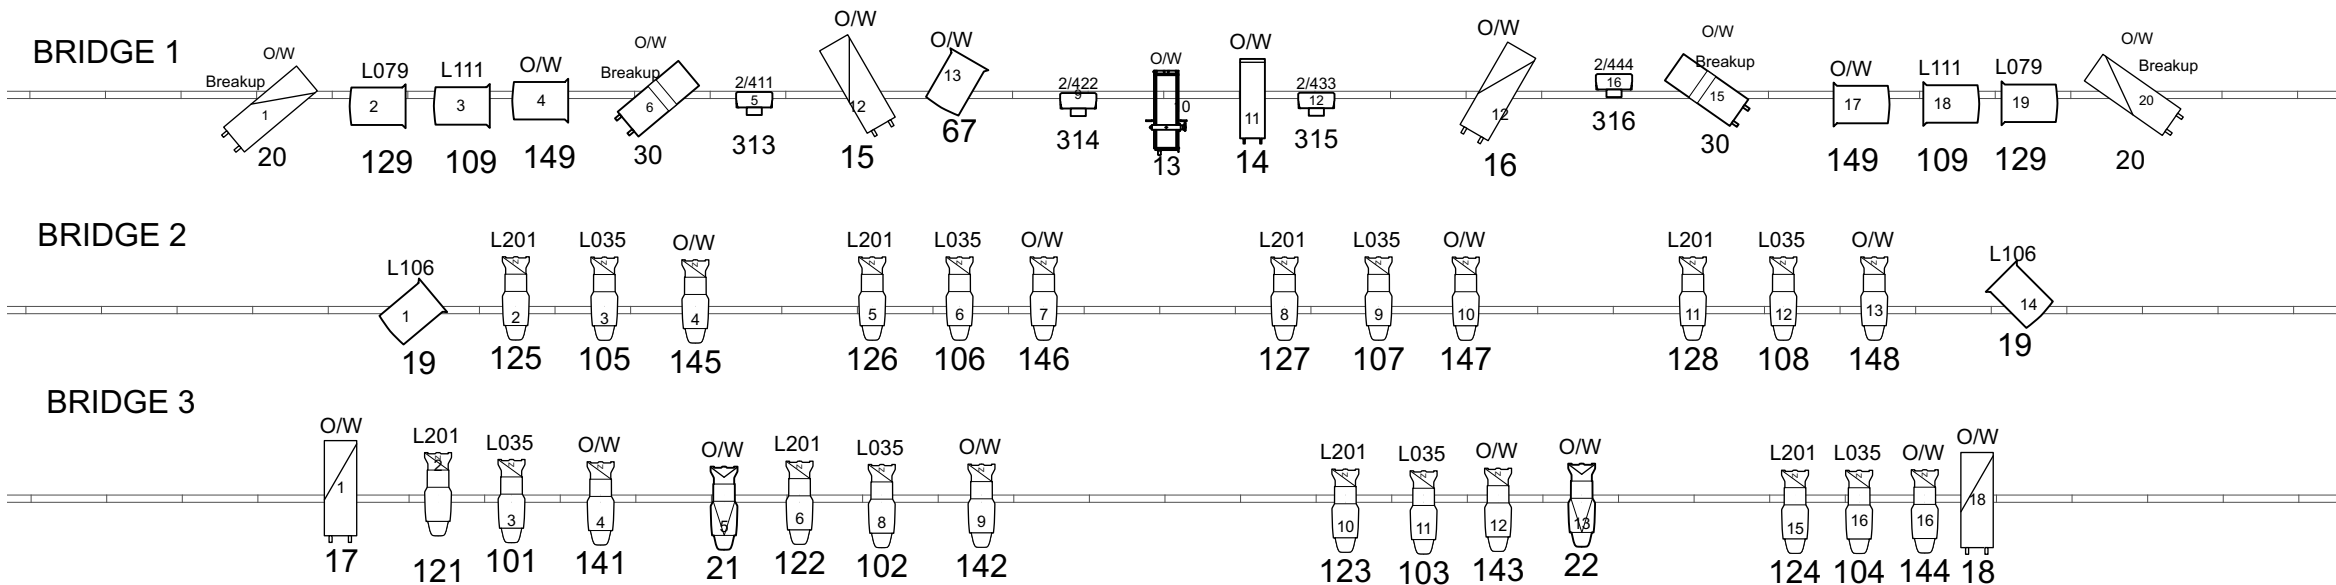


FOH BRIDGES



Symbol Key

	Strand Cantata 18-32 @ 1.2kw T29	9
	Strand Cantata 26-44 @ 1.2kw T29	7
	ShowPro LED PAR Quad-18 @ 144w LED	16
	ETC Source4 Zoom 15-30deg 750W @ 750w HPL	24
	Selecon Rama Fresnel @ 1.2kw BTN/BTR	33
	Strand Prelude 16-30 @ 600 w RSE/18	10
	Strand SL 15/32 Zoom @ 575w	0

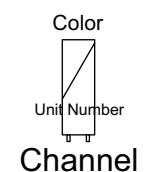

STANDARD RIG LIGHTING PLAN

DAREBIN ARTS CENTRE

FOH BRIDGES

SCALE: 1:50 @ A3

DATE:

DRAWN BY: Luke Ketchell

28/2/2024