



FULL RIG

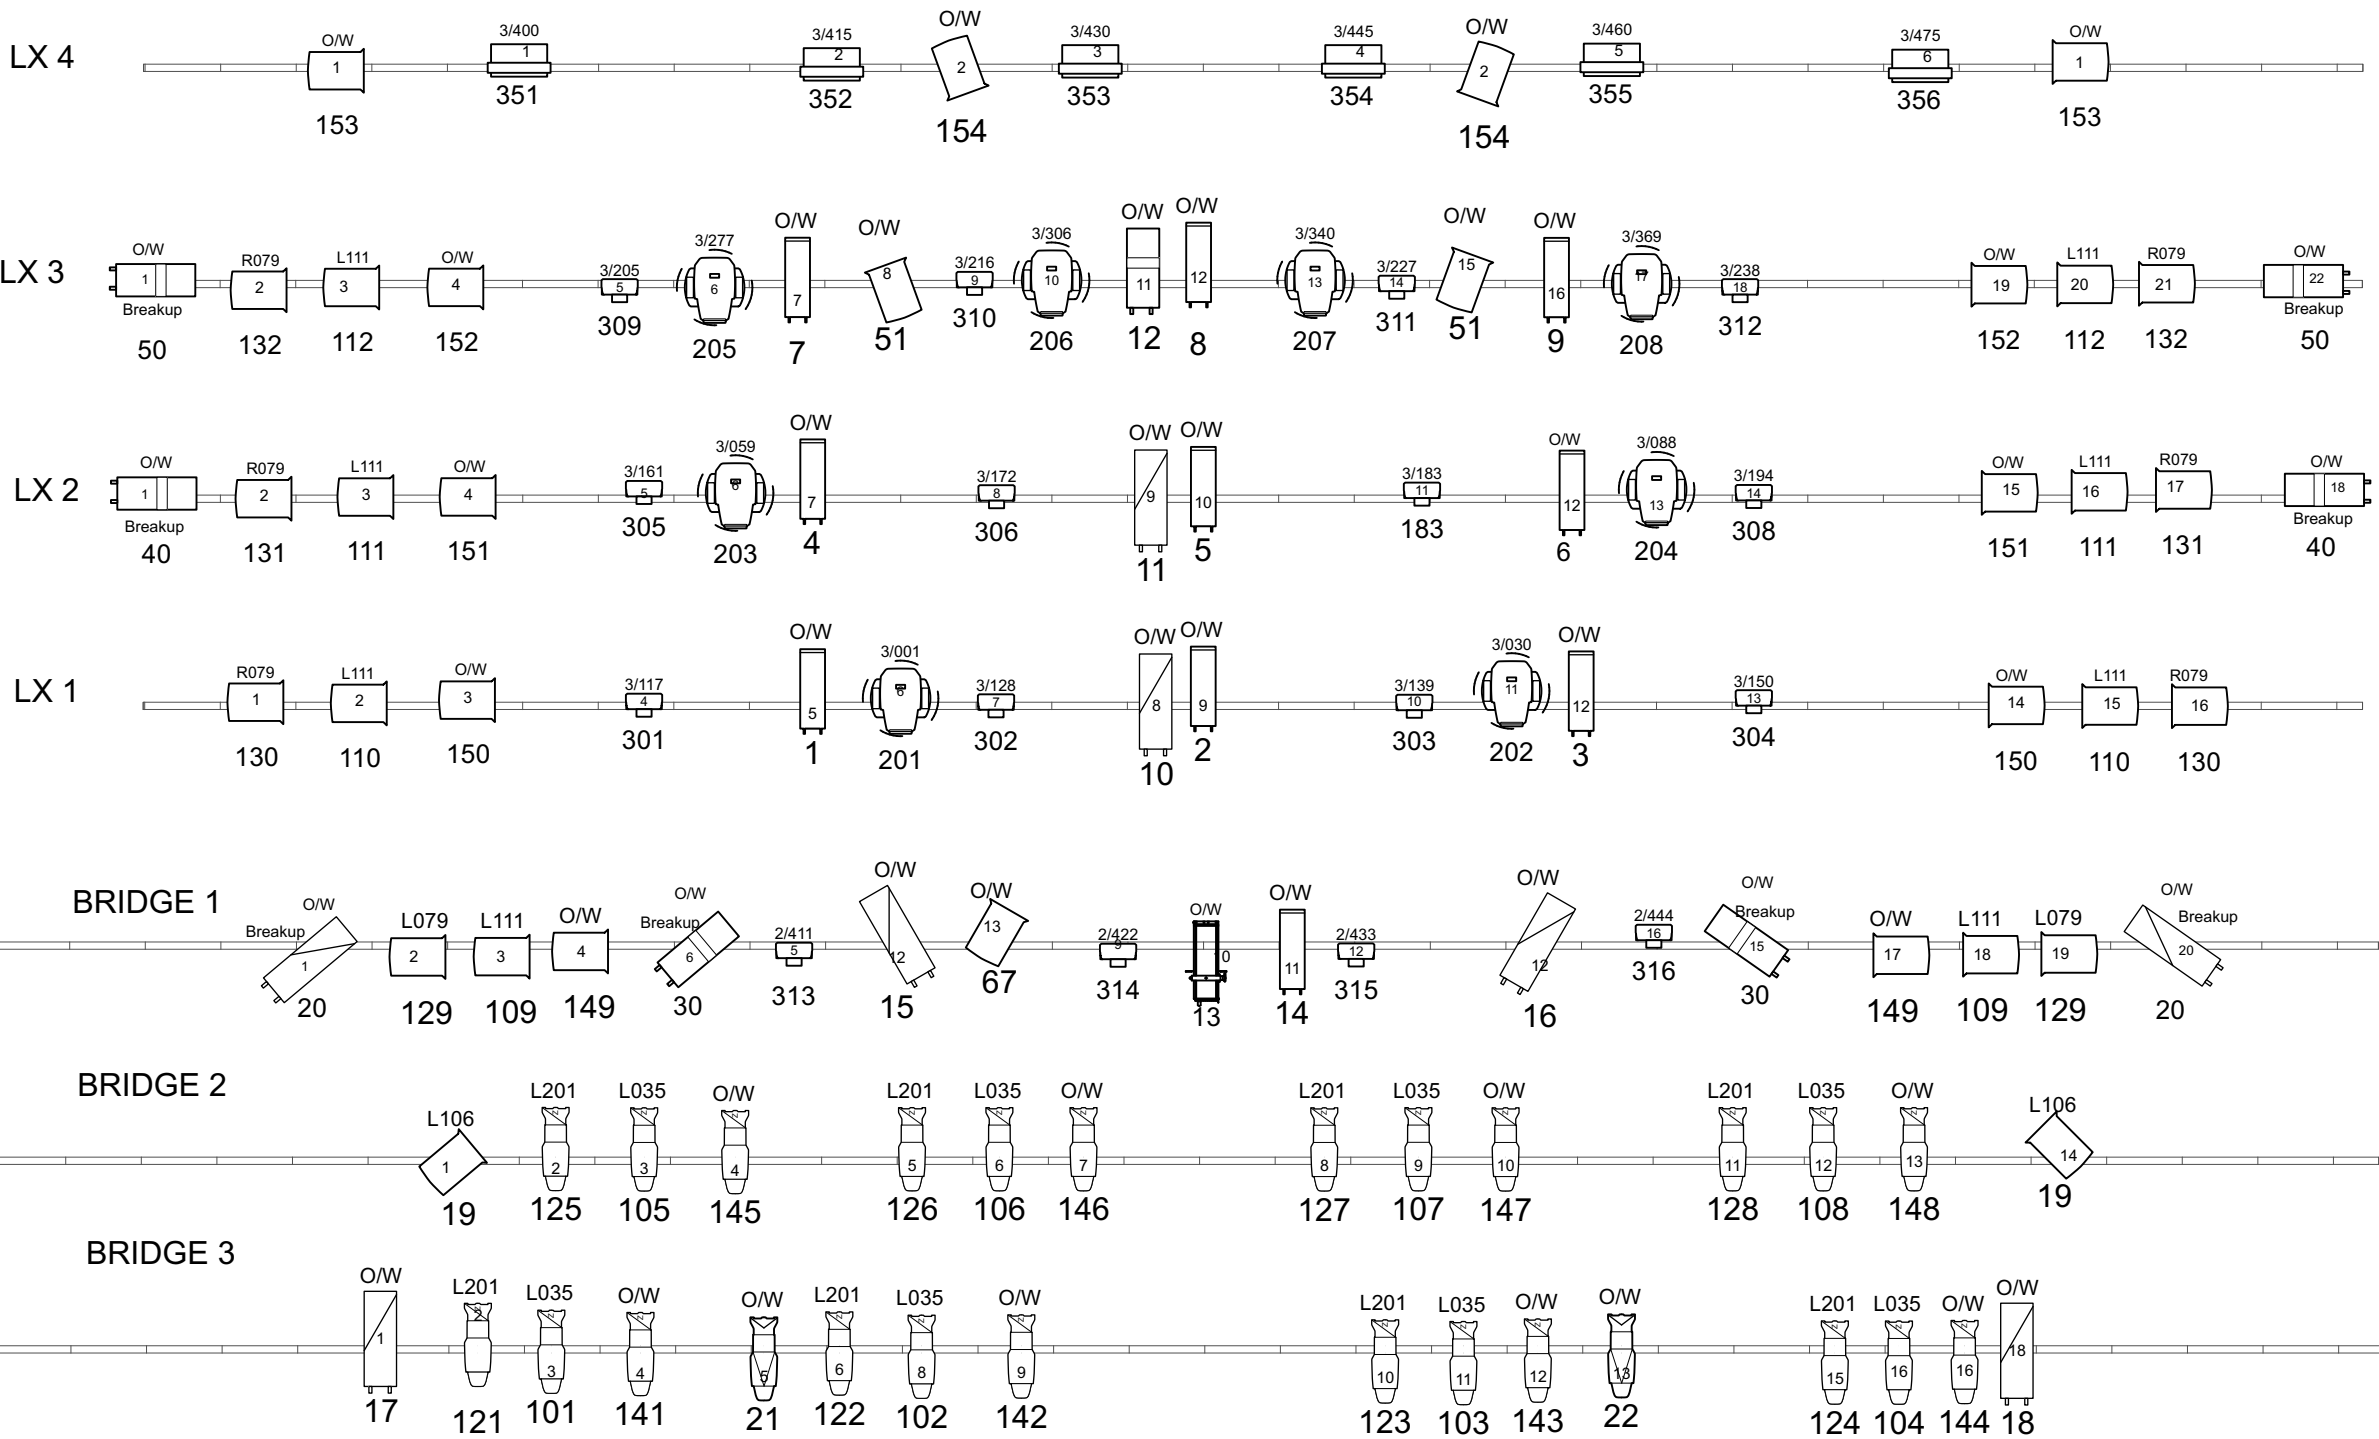

Symbol Key

- ETC Source4 Zoom 15-30deg 750W @ 750w 24
- Selecon Rama Fresnel @ 1.2kw 33
- FusionPar Q XII 11 Chan 16
- Strand Cantata 18-32 @ 1.2kw 9
- Strand Cantata 26-44 @ 1.2kw 7
- Infinity TCyc-7 LED 6
- Strand SL 15/32 Zoom @ 575w 0
- Strand Prelude 16-30 @ 600 w 10
- Highlite Infinity TS-260C7 LED Profile 750W @ 260w 2
- Moving Light
- Chauvet Maverick MK1 Spot @ 592w 8

 Legend



STANDARD RIG LIGHTING PLAN

DAREBIN ARTS CENTRE

FULL RIG

SCALE: 1:50 @ A3

DATE:

DRAWN BY: Luke Ketchell

28/02/2024