


LX BARS

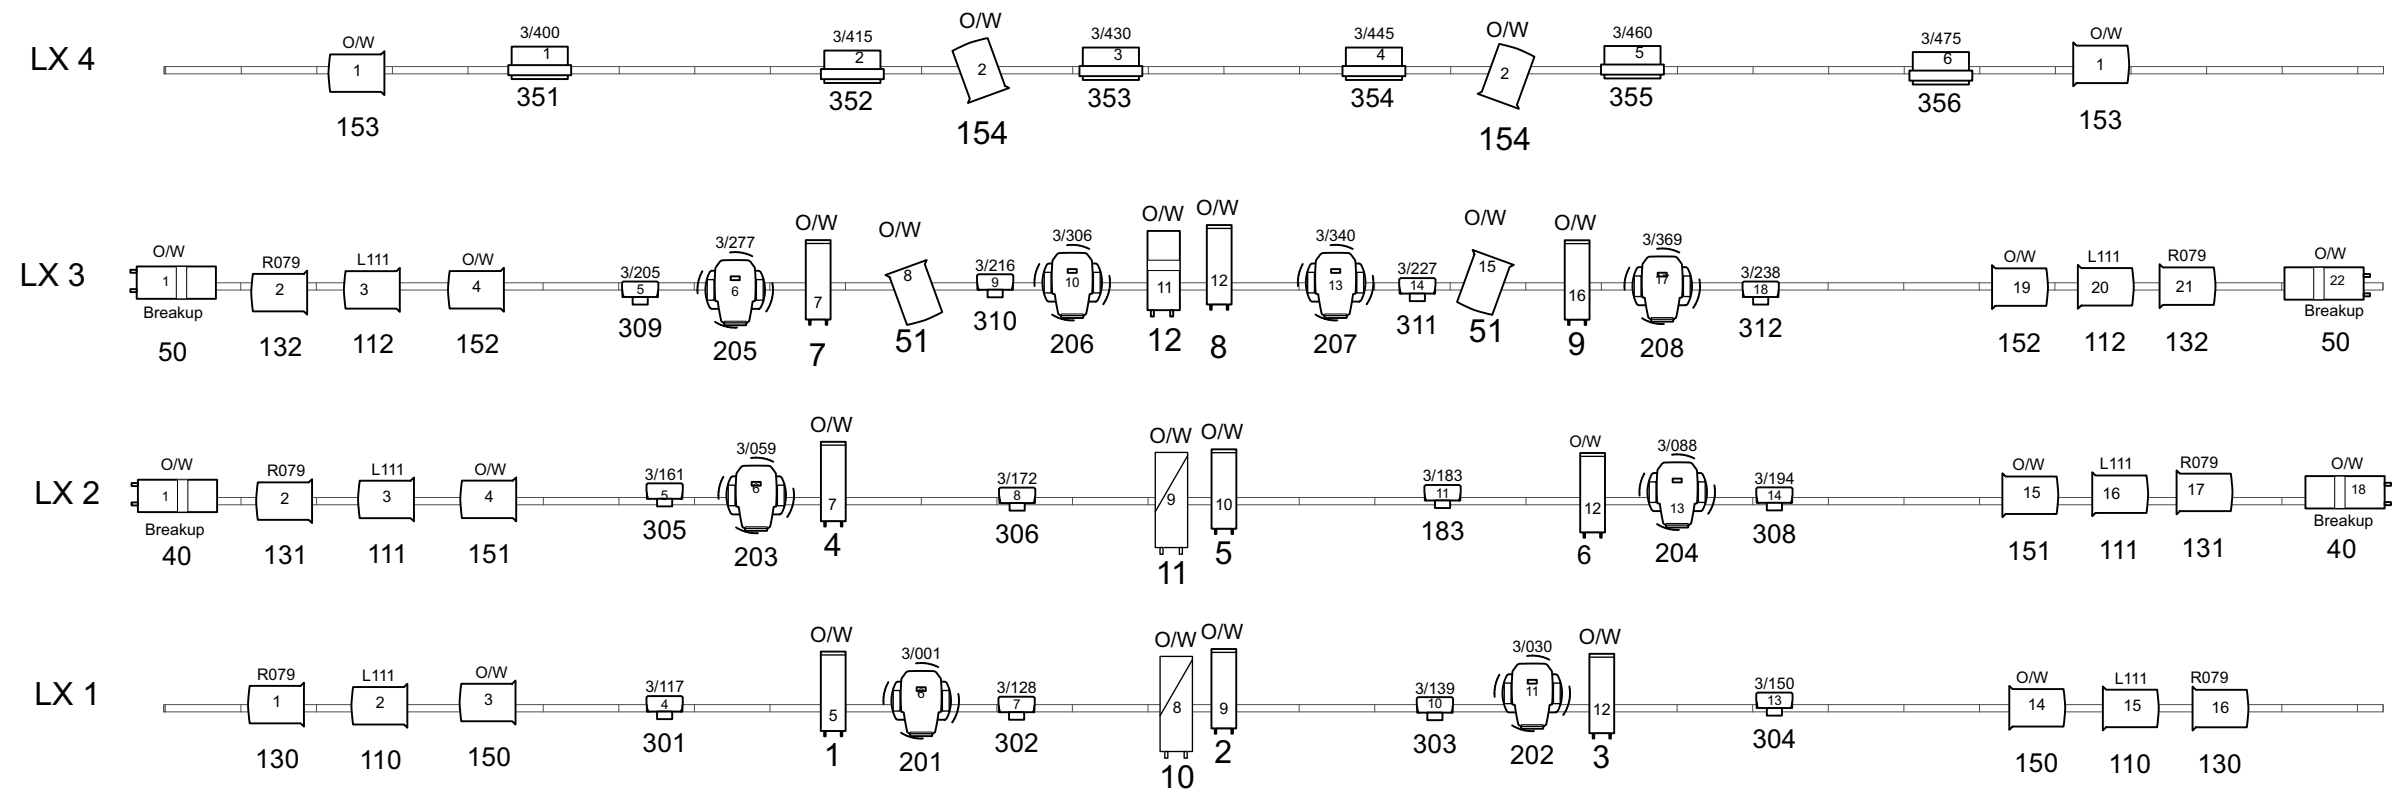

Symbol Key

Strand
Cantata
26-44 @
1.2kw

7

Chauvet
Maverick
MK1 Spot @
592w

8

Selecon
Rama
Fresnel @
1.2kw

33

Strand Iris 4
@ 1.25kw

0

Strand
Prelude
16-30 @ 600
w

10

Highlite
Infinity
TS-260C7
LED Profile
750W @
260w

2

Legend

Color

Unit Number

Channel

STANDARD RIG LIGHTING PLAN		
DAREBIN ARTS CENTRE		LX BARS
SCALE:	1:50 @ A3	DATE:
DRAWN BY:	Luke Ketchell	28/2/2024